


Quantity Symbol Name

- 114 3mm White PST Panel [980mm x 2316mm]
- 32 Plug Point
- 60 PST Facia 2980x216
- 64 Scan LED Long Arm Light
- 228 UA4849_964 extra wide 2-way 50mm
- 120 UA4849_2964 extra wide 2-way 50mm
- 150 UA6222_2400 4-way 2.5 profile

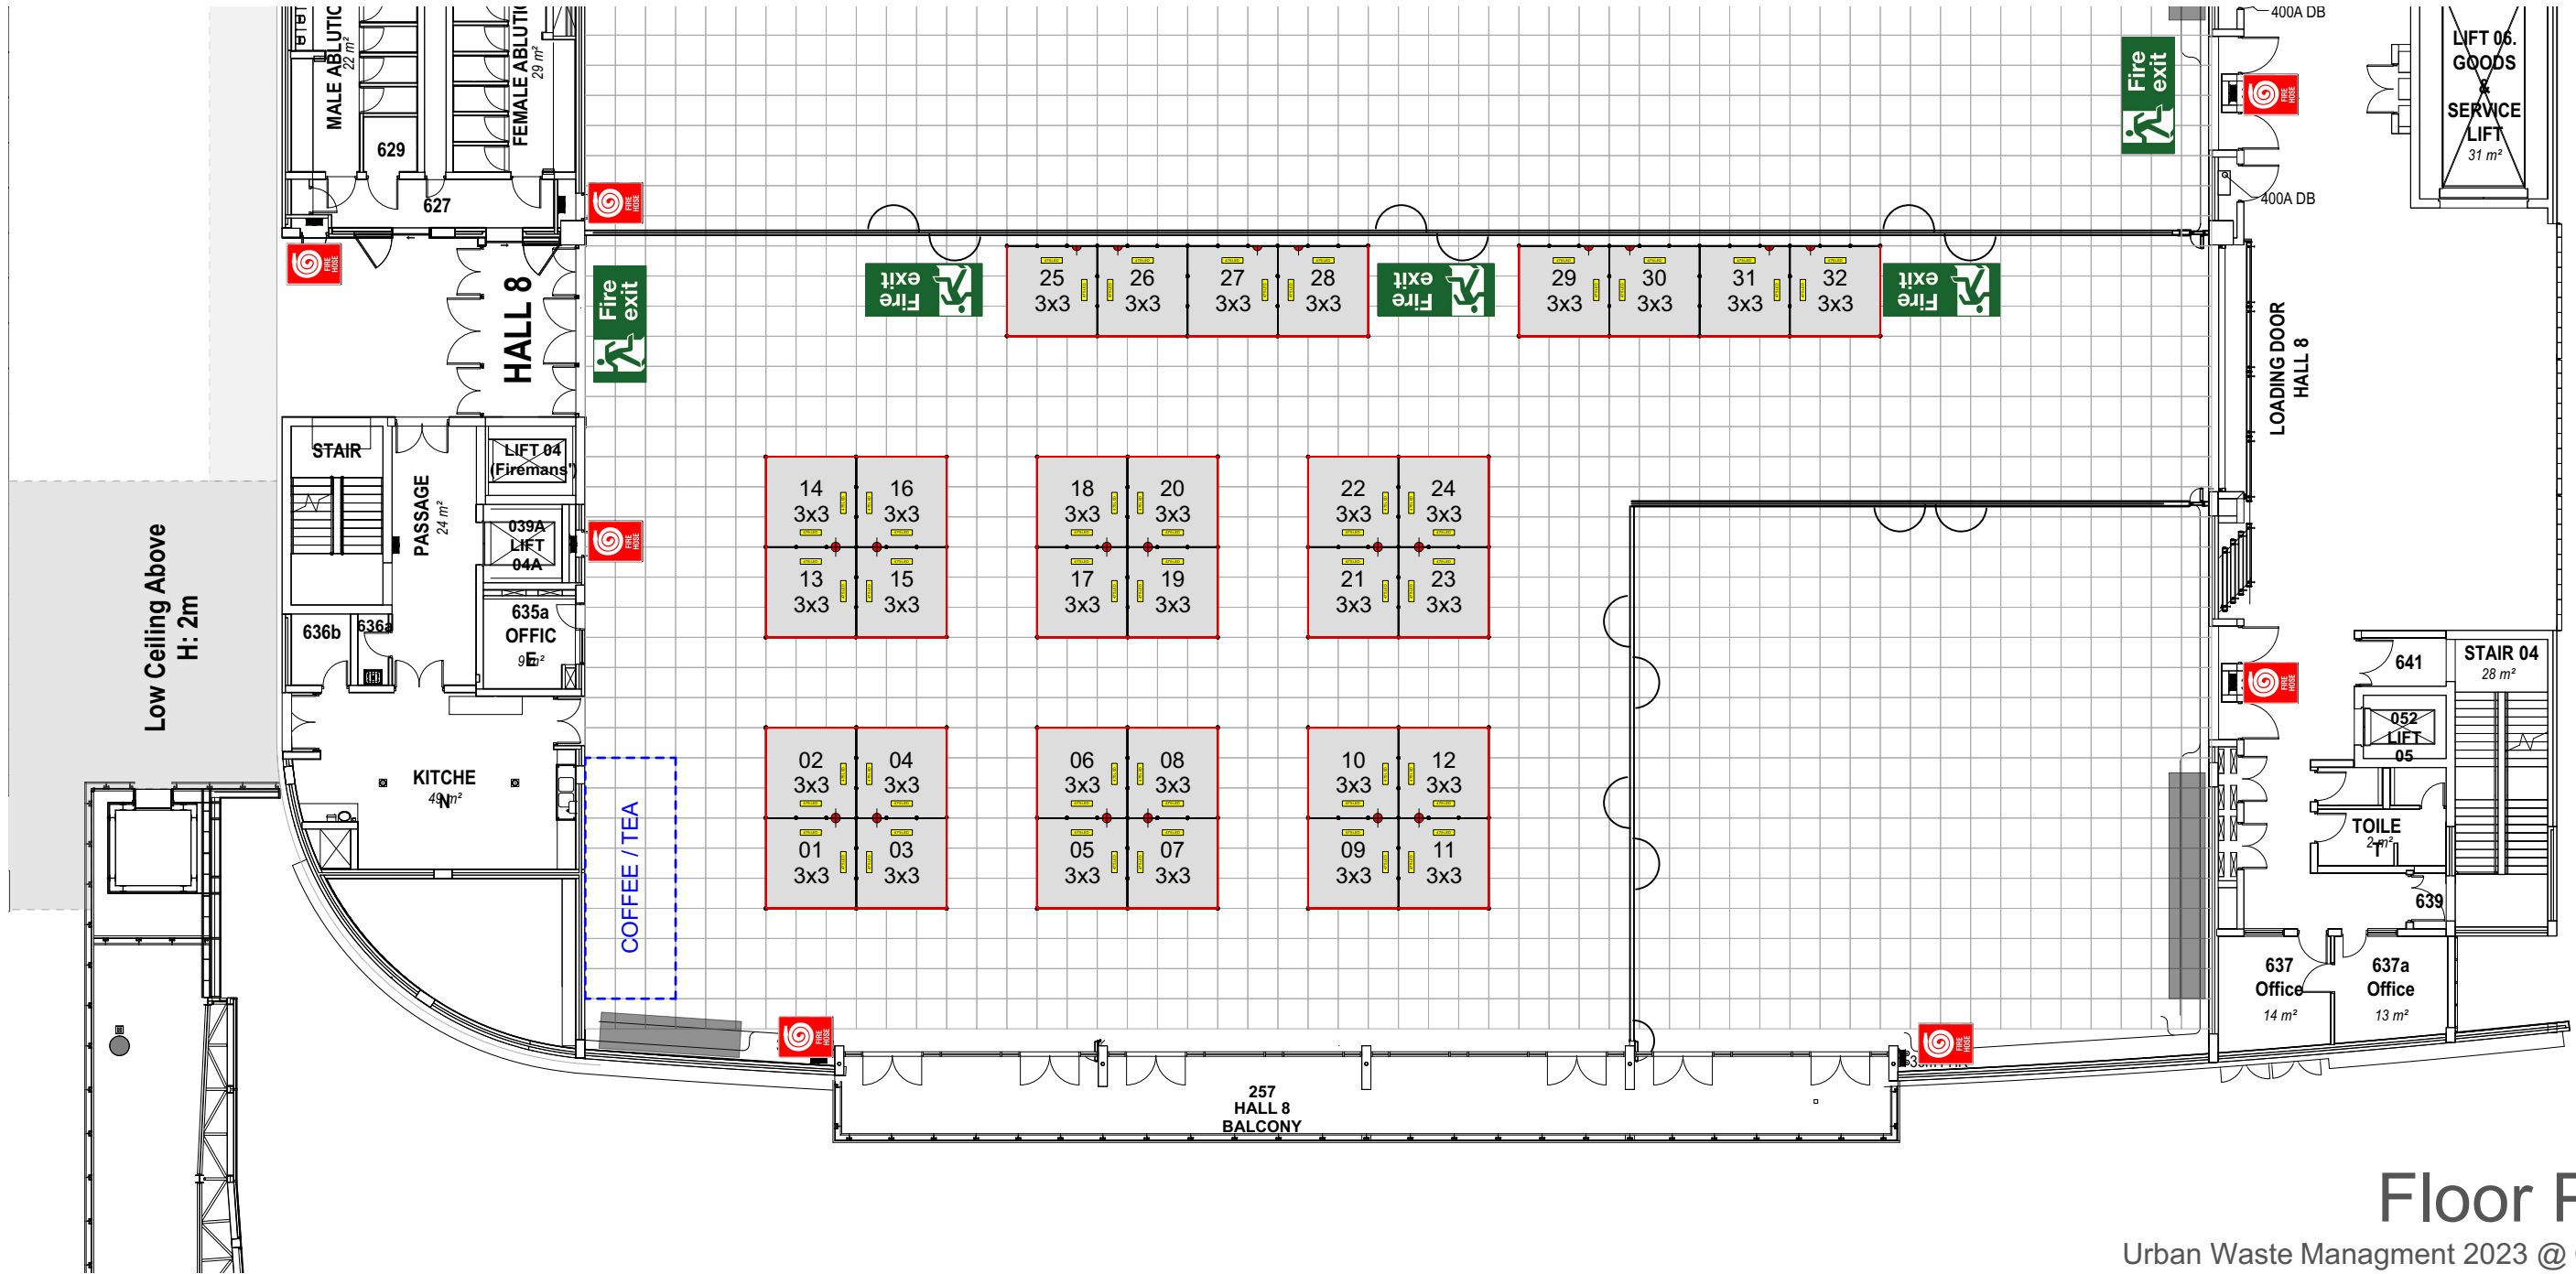

Floor Plan

Urban Waste Management 2023 @ CTICC 2

Buildup dates: 17 May 2023

Show Dates: 18-19 May 2023

AE brandon@scandisplay.co.za
DESIGN jacob.vz@scandisplay.co.za

DWG NO: 441/rev1
2023-05-03



© 2016 - This proposal and design used in this concept are each subject to the national and international copyright laws for the protection of intellectual property rights. It is not allowed to duplicate or hand out this concept and design or any part of it to third parties. Please note that any dissemination to third parties, distribution or copying of this concept and design is prohibited. All dimensions and relevant details to be checked by production and pre-built prior to construction on site. All dimensions are given in mm. Any discrepancies are to be reported to the designer immediately. No changes are to be made to this design without the approval of the designer. Colours and graphics are represented as close as possible but may differ from the actual finished product.



Isometric View

Urban Waste Management 2023 @ CTICC 2

Buildup dates: 17 May 2023

Show Dates: 18-19 May 2023

AE brandon@scandisplay.co.za
 DESIGN jacob.vz@scandisplay.co.za

DWG NO: 441/rev1
 2023-05-03